




AREA WEST OF LONDON
Sec. 24, T. 8 N., R. 22 W.
Sec. 16, T. 8 N., R. 21 W.
Scale Three Times map scale

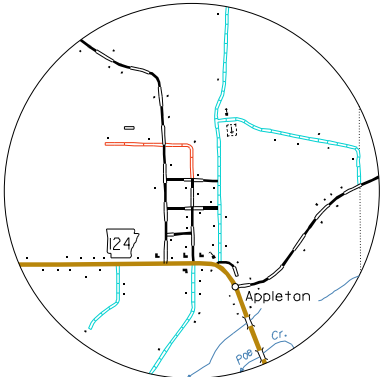


APPLETON
Sec. 13, 14, T. 9 N., R. 18 W.

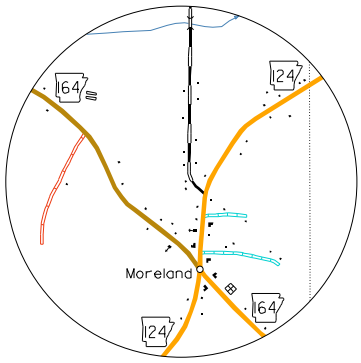

MORELAND
Sec. 2, 3, T. 8 N., R. 19 W.

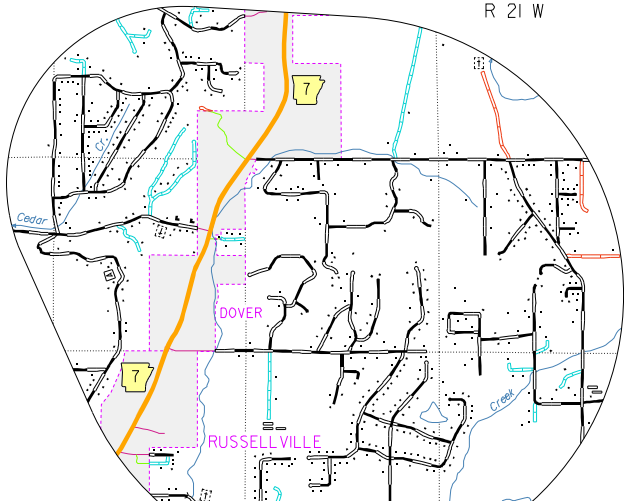

DOVER-RUSSELLVILLE AREA
Sec. 2-5, 8-11, 14-16, 21-23, T. 8 N., R. 20 W.
Scale Two Times map scale

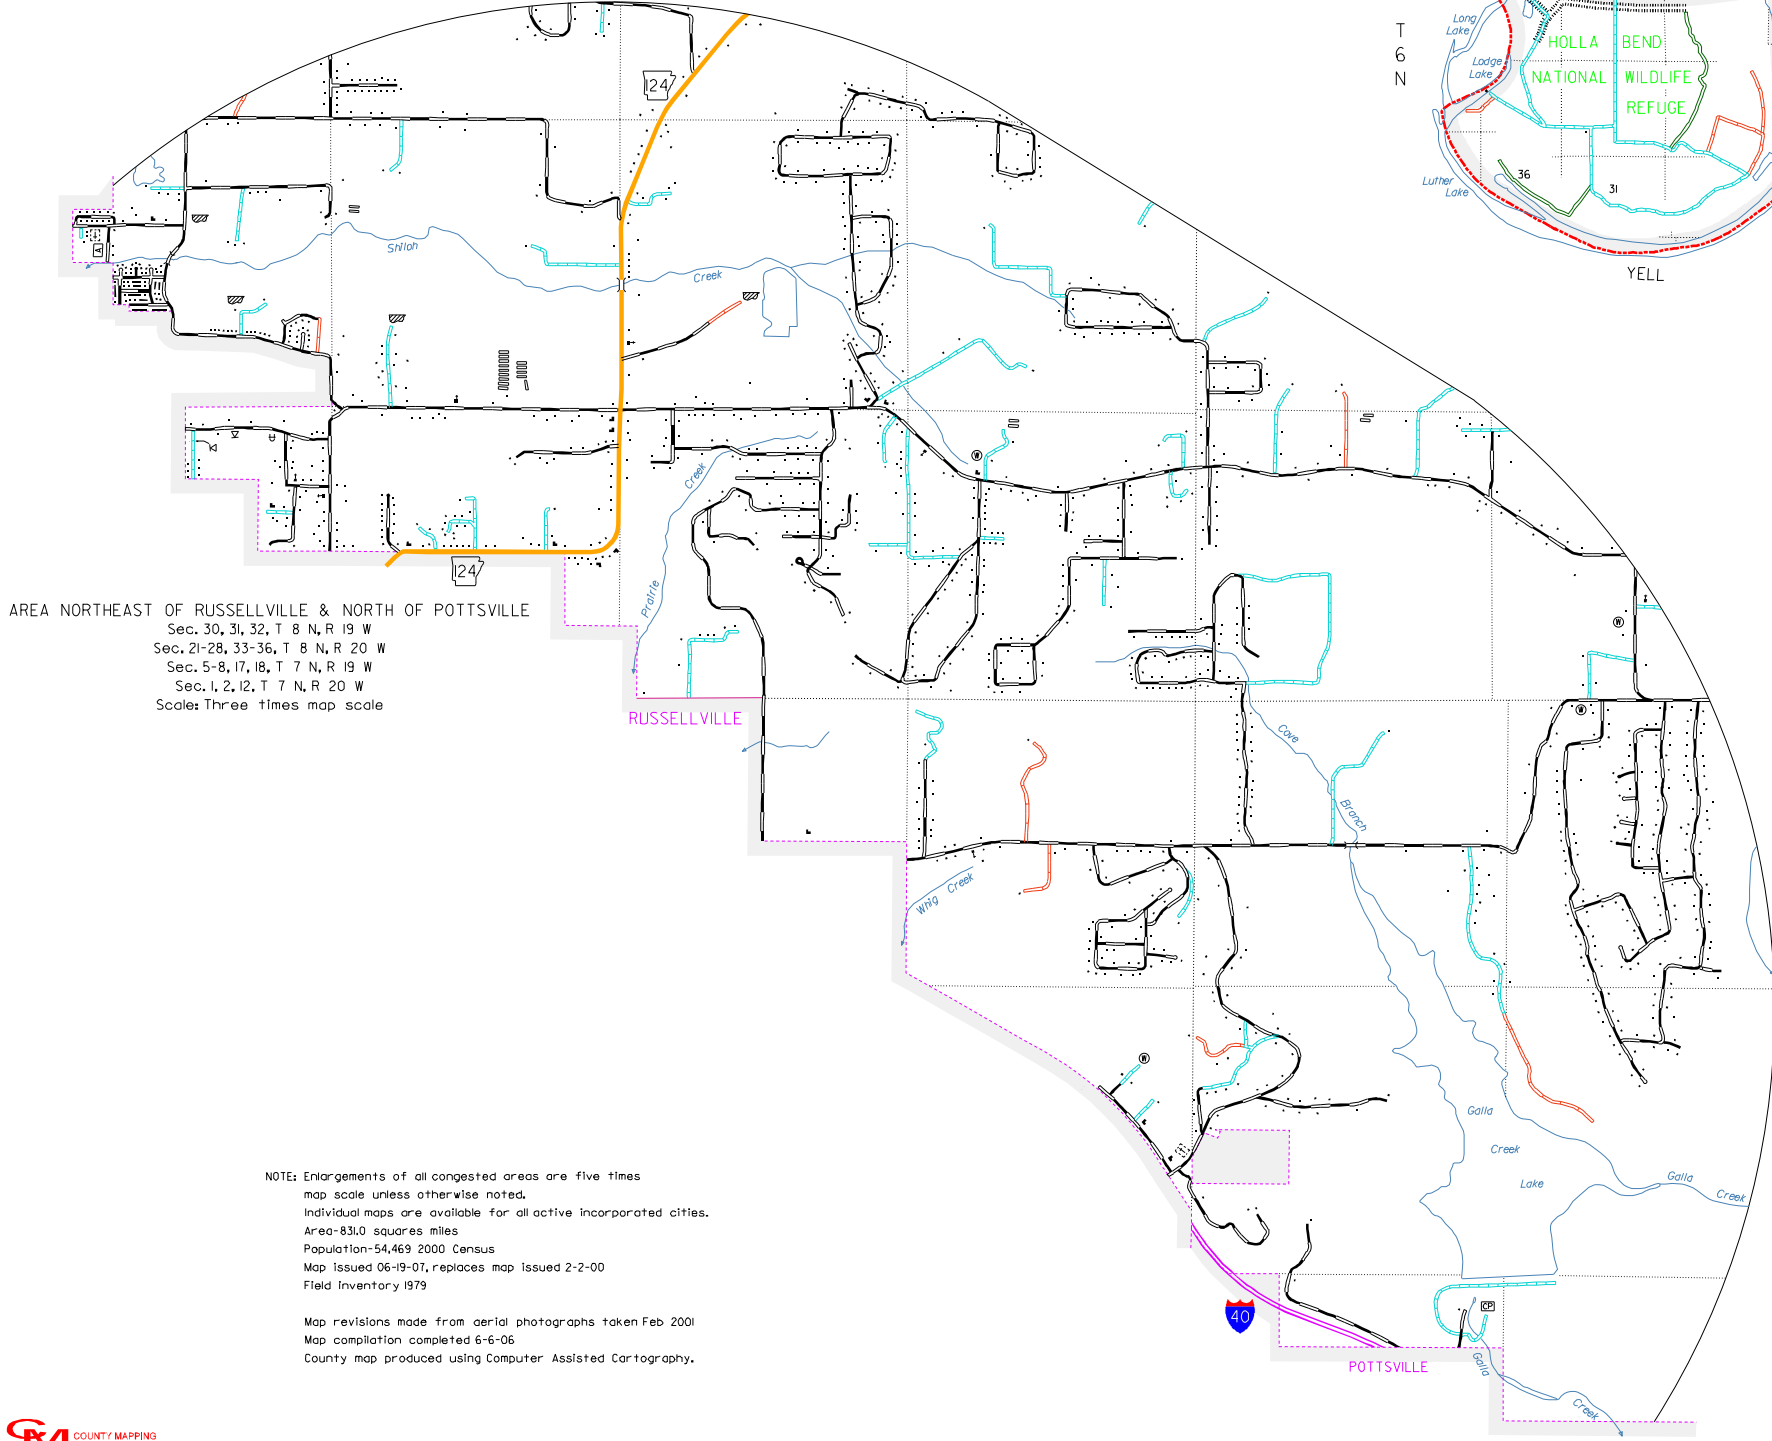

AREA NORTHEAST OF RUSSELLVILLE & NORTH OF POTTSVILLE
Sec. 30, 31, 32, T. 8 N., R. 19 W.
Sec. 21-23, 33-36, T. 8 N., R. 20 W.
Sec. 5-8, 17, 18, T. 7 N., R. 19 W.
Sec. 1, 2, 21, T. 7 N., R. 20 W.
Scale Three Times map scale

NOTES: Enlargements of all congested areas are five times map scale unless otherwise noted.
Individual maps are available for all active incorporated cities.
Area 83.0 square miles
Population 14,469 2000 Census
Map issued 06-19-01, reissues map issued 2-2-00
Field inventory 1979
Map revisions made from aerial photographs taken Feb 2001
Map compilation completed 6-6-06
County map produced using Computer Assisted Cartography.

- LEGEND
- COUNTY BOUNDARY
 - STATE OR COUNTY LINE INDETERMINATE
 - U.S. LAND TOWNSHIP LINE
 - SECTION LINE
 - NATIONAL FOREST BOUNDARY
 - PARK OR RESERVATION BOUNDARY
 - PAVED STATE OR U.S. HIGHWAY
 - DIVIDED HIGHWAY (Paved or more lanes, divided, center line, double yellow, or double white)
 - INTERSTATE HIGHWAY
 - U.S. NUMBERED HIGHWAY
 - STATE HIGHWAY
 - PAVED LOCAL ROAD
 - GRAVEL OR DIRTED LOCAL ROAD
 - UNPAVED LOCAL ROAD
 - INTERCHANGE
 - RAILROAD
 - RAILROAD STATION
 - GRADE CROSSING
 - OVERPASS
 - UNDERPASS
 - HIGHWAY BRIDGE (60 FEET OR MORE IN LENGTH)
 - PAVED FORD OR LOW WATER BRIDGE
 - LEVEE OR DIKE
 - LEVEE WITH ROAD
 - MEADE BETWEEN POINTS
 - LAKE, RESERVOIR OR POND
 - LAKE, RESERVOIR OR POND WITH DAM
 - MARSH OR SWAMP
 - WIDE RIVER OR STREAM
 - DOCK, PIER OR LANDING
 - NAVIGABLE STREAM
 - DAM WITH LOCK
 - SMALL STREAM
 - DRAINAGE DITCH
 - CORPORATE LIMITS AND ROADS THROUGH TOWN
 - COUNTY SEAT
 - OTHER CITIES AND TOWNS
 - MUNICIPAL AIRPORT
 - PRIVATE AIRFIELD
 - FARM UNIT OR DWELLING
 - GROUP OF CLOSELY SPACED DWELLINGS (if no figure shown)
 - CHURCH OR OTHER RELIGIOUS INSTITUTION
 - HOSPITAL
 - SCHOOL
 - POST OFFICE + POST OFFICE AND BUSINESS
 - CEMETERY
 - CHURCH WITH CEMETERY ADJACENT
 - BUSINESS ESTABLISHMENT
 - FACTORY OR INDUSTRIAL PLANT
 - GRAVEL PIT
 - QUARRY
 - TOWN OR COMMUNITY HALL
 - POWER PLANT
 - FIRE ENGINE HOUSE
 - POWER SUBSTATION
 - TRAILER PARK
 - CAMP OR LODGE
 - GOLF COURSE OR COUNTRY CLUB
 - ATHLETIC FIELD OR AMUSEMENT PARK
 - SMALL PARK (up to 100 acres or less)
 - WATER SUPPLY STANDPIPE OR TANK
 - CHICKEN HOUSE OR OTHER LIVESTOCK
 - PICNIC GROUND
 - SCENIC HIGHWAY

- 13 CEMETERY
- 14 CHURCH WITH CEMETERY ADJACENT
- 15 BUSINESS ESTABLISHMENT
- 16 FACTORY OR INDUSTRIAL PLANT
- 17 GRAVEL PIT
- 18 QUARRY
- 19 TOWN OR COMMUNITY HALL
- 20 POWER PLANT
- 21 FIRE ENGINE HOUSE
- 22 POWER SUBSTATION
- 23 TRAILER PARK
- 24 CAMP OR LODGE
- 25 GOLF COURSE OR COUNTRY CLUB
- 26 ATHLETIC FIELD OR AMUSEMENT PARK
- 27 SMALL PARK (up to 100 acres or less)
- 28 WATER SUPPLY STANDPIPE OR TANK
- 29 CHICKEN HOUSE OR OTHER LIVESTOCK
- 30 PICNIC GROUND
- 31 SCENIC HIGHWAY

GENERAL HIGHWAY MAP
POPE COUNTY
ARKANSAS
PREPARED BY
ARKANSAS STATE HIGHWAY AND TRANSPORTATION DEPARTMENT
PLANNING AND RESEARCH DIVISION
IN COOPERATION WITH
U.S. DEPARTMENT OF TRANSPORTATION
FEDERAL HIGHWAY ADMINISTRATION
SCALE 1:62,500
MILES
KILOMETERS

Copies of this map are available at a nominal fee from the Arkansas State Highway and Transportation Department, P.O. Box 226 Little Rock, Ark. 72203



Polyconic Projection-North American Datum